


FIXTURE CONNECTION SCHEDULE				
Symbol	C.W.	H.W.	Waste/Vent	Remarks
W.C.	1"	—	4"	2"
U	3/4"	—	2"	2"
LAV	1/2"	1/2"	1 1/2"	1 1/2"
W.F.	3/4"	3/4"	2"	2"
SS	3/4"	—	2"	2"
SK-1	1/2"	1/2"	2"	1 1/2"
SK-2	1/2"	1/2"	2"	1 1/2"
SK-3	1/2"	1/2"	2"	1 1/2"
SK-4	1/2"	—	2"	1 1/2"
DF	3/4"	—	1 1/2"	1 1/2"
HB	3/4"	—	2"	2"
FD	—	—	2 3/4"	2"

Install foot operated valves on the two existing Bradley wash fountains.

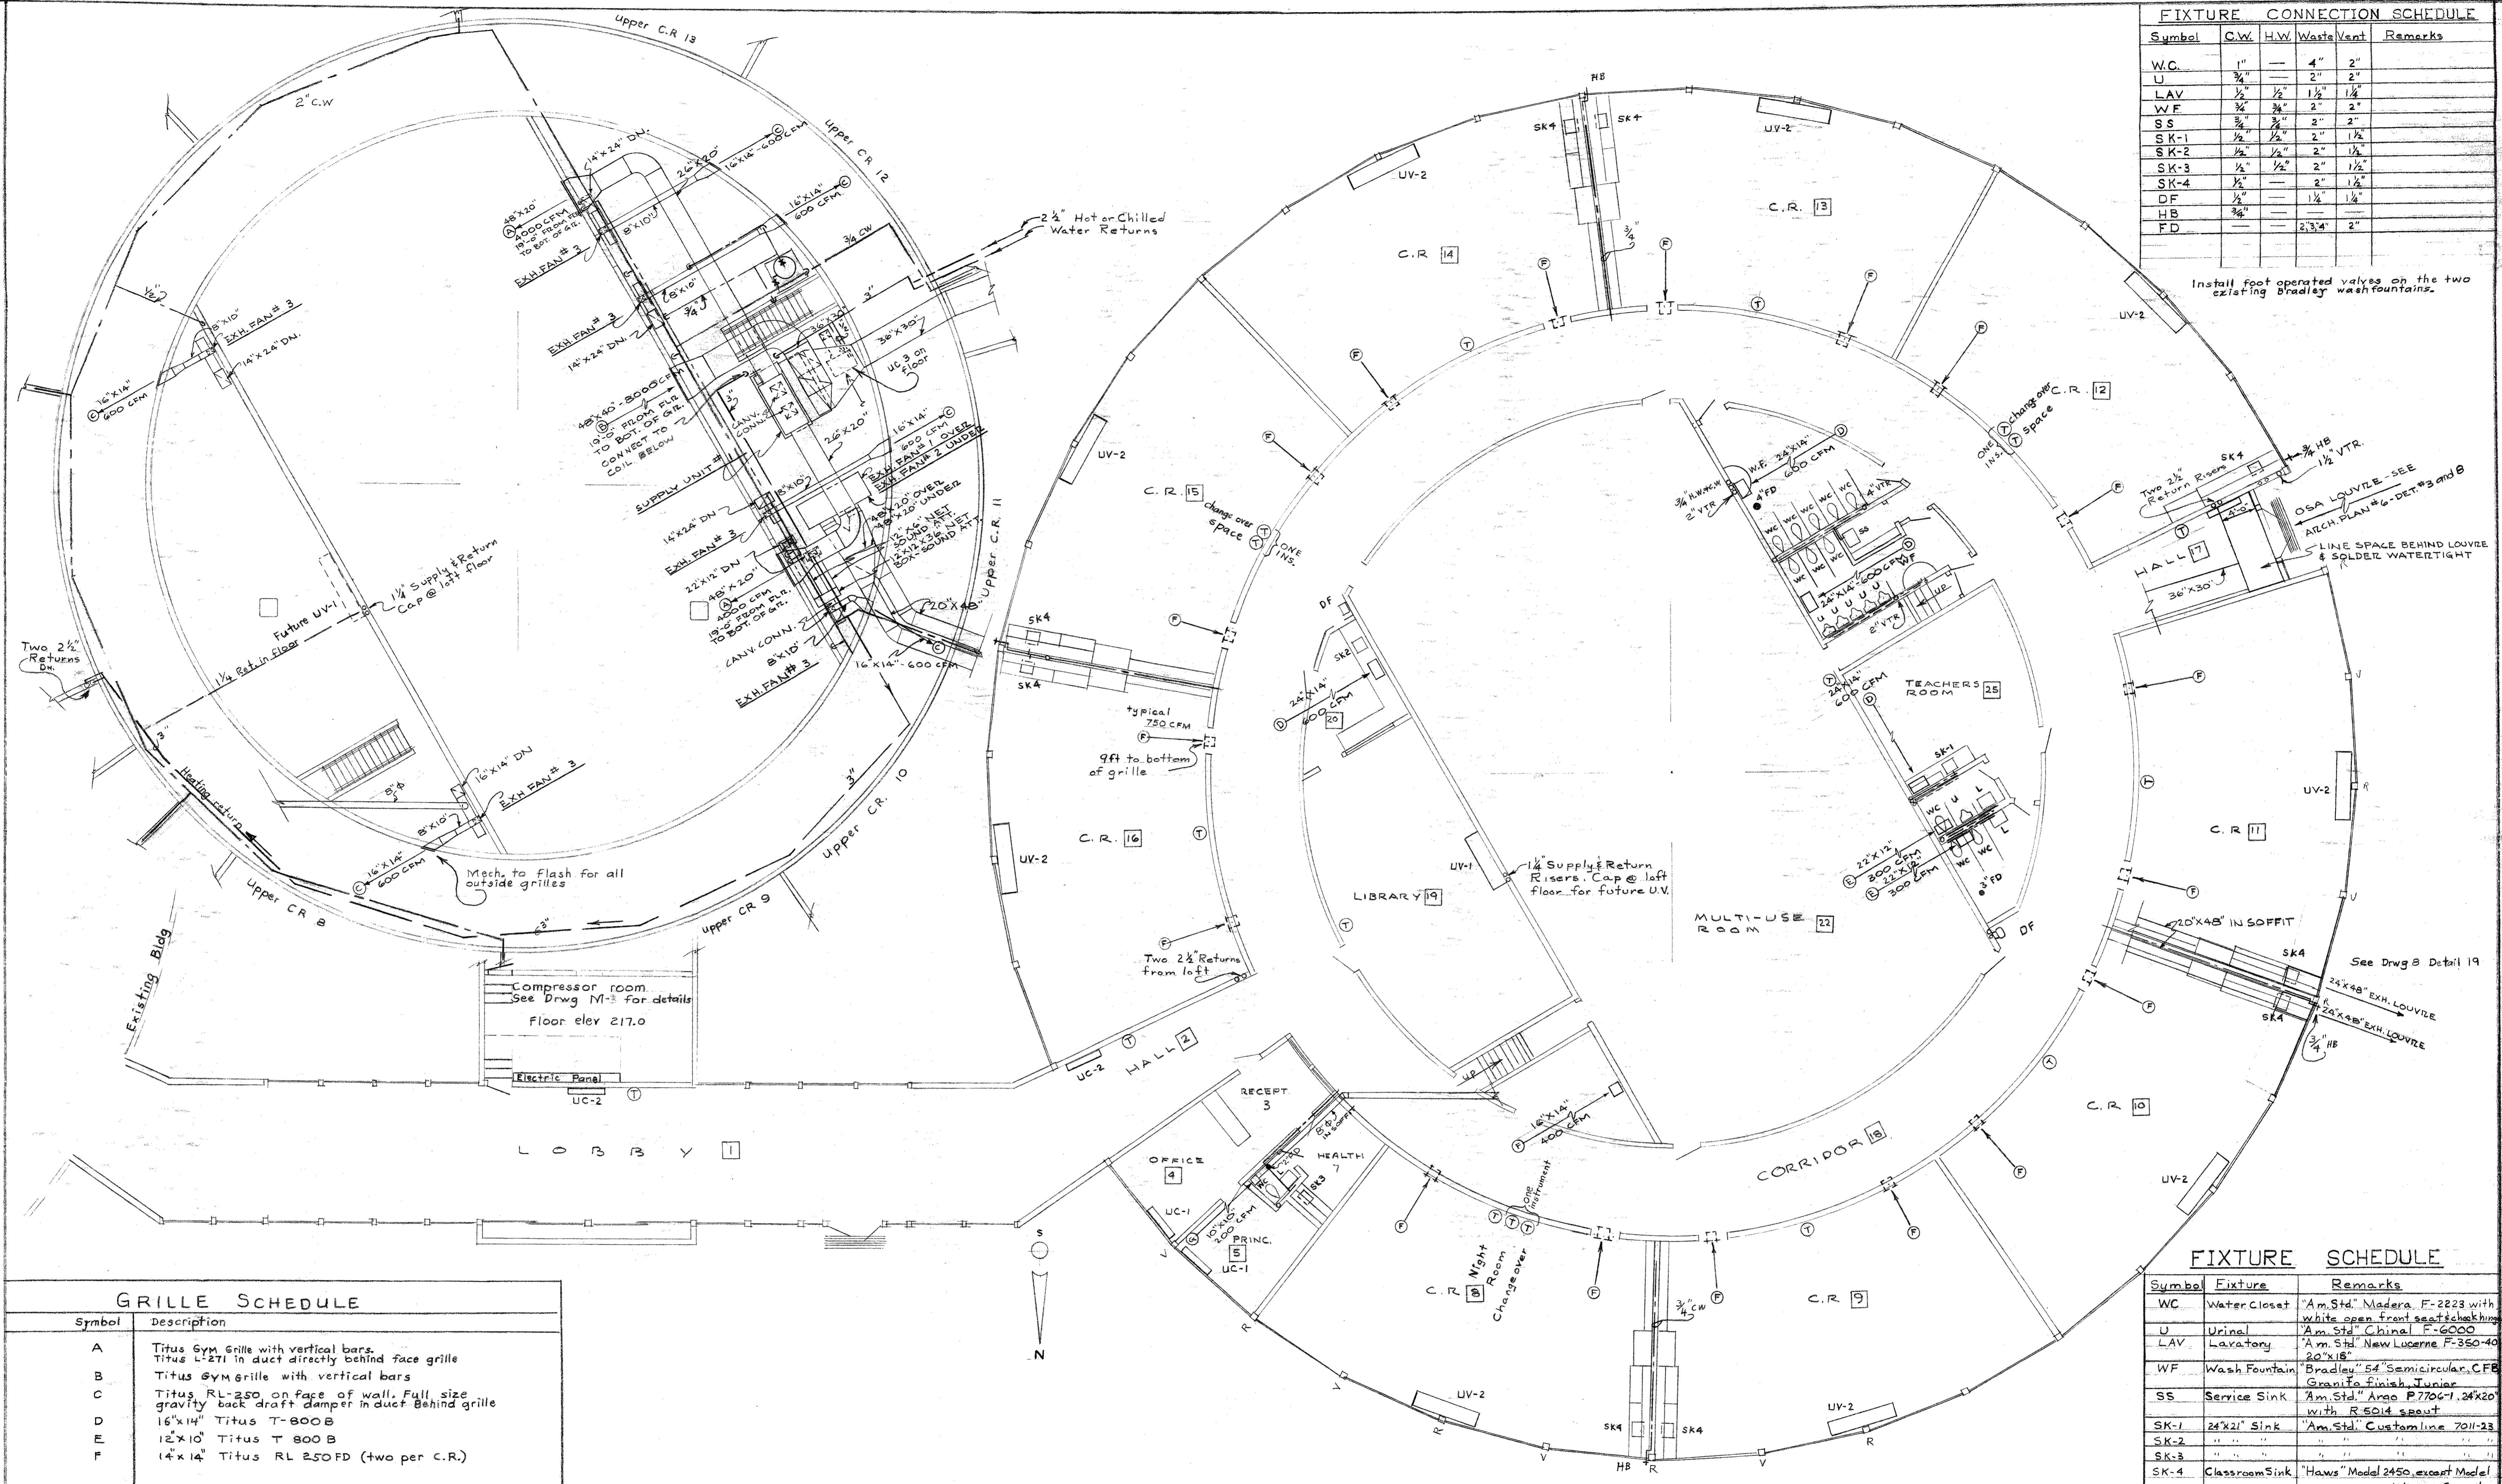

GRILLE SCHEDULE	
Symbol	Description
A	Titus Gym grille with vertical bars. Titus L-271 in duct directly behind face grille
B	Titus Gym grille with vertical bars
C	Titus RL-250 on face of wall. Full size gravity back draft damper in duct Behind grille
D	16"x14" Titus T-800B
E	12"x10" Titus T 800B
F	14"x14" Titus RL 250FD (two per C.R.)

FIXTURE SCHEDULE		
Symbol	Fixture	Remarks
WC	Water Closet	"Am. Std." Madera F-2223 with white open front seat/flushing
U	Urinal	"Am. Std." China F-6000
LAV	Lavatory	"Am. Std." New Lucerne F-350-40 20"x18"
WF	Wash Fountain	"Bradley" 54" Semicircular, CFB Granite finish, Junior
SS	Service Sink	"Am. Std." Arco P7704-1, 24"x20" with R-5014 sprout
SK-1	24"x21" Sink	"Am. Std." Customline 7011-23
SK-2	"	"
SK-3	"	"
SK-4	Classroom Sink	"Haws" Model 2450, except Model 244 D.F. Model 419A faucet
WH-1	Water Heater	"Nat'l." ARGL 66, 3000W, 423V
WH-2	"	"Nat'l." ER 1 1/2, 750W, 230V
WH-3	"	"Nat'l." ERGL 20C, 18KW, 480V with integral "thermostat"

CLASSROOM UNIT PLAN
SCALE 1/8" = 1'-0"

OMER T. JACOBSON CONSULTING MECHANICAL ENGINEER 1305 S.E. BELMONT PORTLAND 14, OREGON	JAMES C. GARDINER REGISTERED ARCHITECT 3158 S.W. 87th AVENUE - PORTLAND, OREGON - CY 2-3727	ADDITION TO VOSE ELEMENTARY SCHOOL SCHOOL DIST NO. 48 WASHINGTON COUNTY, OREGON	
		DATE: 1-18-62 FILE NO: 21-691	TITLE OF SHEET FLOOR PLAN